



PACKAGE B: ENGINEERING SERVICE TENDER DRAWINGS

REIMAGINING BARNES HALL


VERSION 02. 14.05.26



PACKAGE B : ENGINEERING SERVICE

DRAWING LIST

S.NO	DRAWING NUMBER	DRAWING TITLE	SCALE	REMARKS
FIRE FIGHTING DRAWINGS				
1	FF/01	FIRE FIGHTING LAYOUT_FIRST FLOOR	NTS	
2	FF/02	FIRE FIGHTING LAYOUT_BALCONY	NTS	
3	FF/03	FIRE FIGHTING LAYOUT_GREEN ROOM	NTS	
HVAC DRAWINGS				
4	HVAC/01	HVAC LAYOUT_FIRST FLOOR	1:100	
5	HVAC/02	HVAC LAYOUT	1:100	
6	HVAC/03	HVAC LAYOUT_MEZANNINE	1:100	
7	HVAC/04	HVAC LAYOUT_SECTION AA'	1:100	
8	HVAC/05	HVAC LAYOUT_SECTION CC'	1:100	

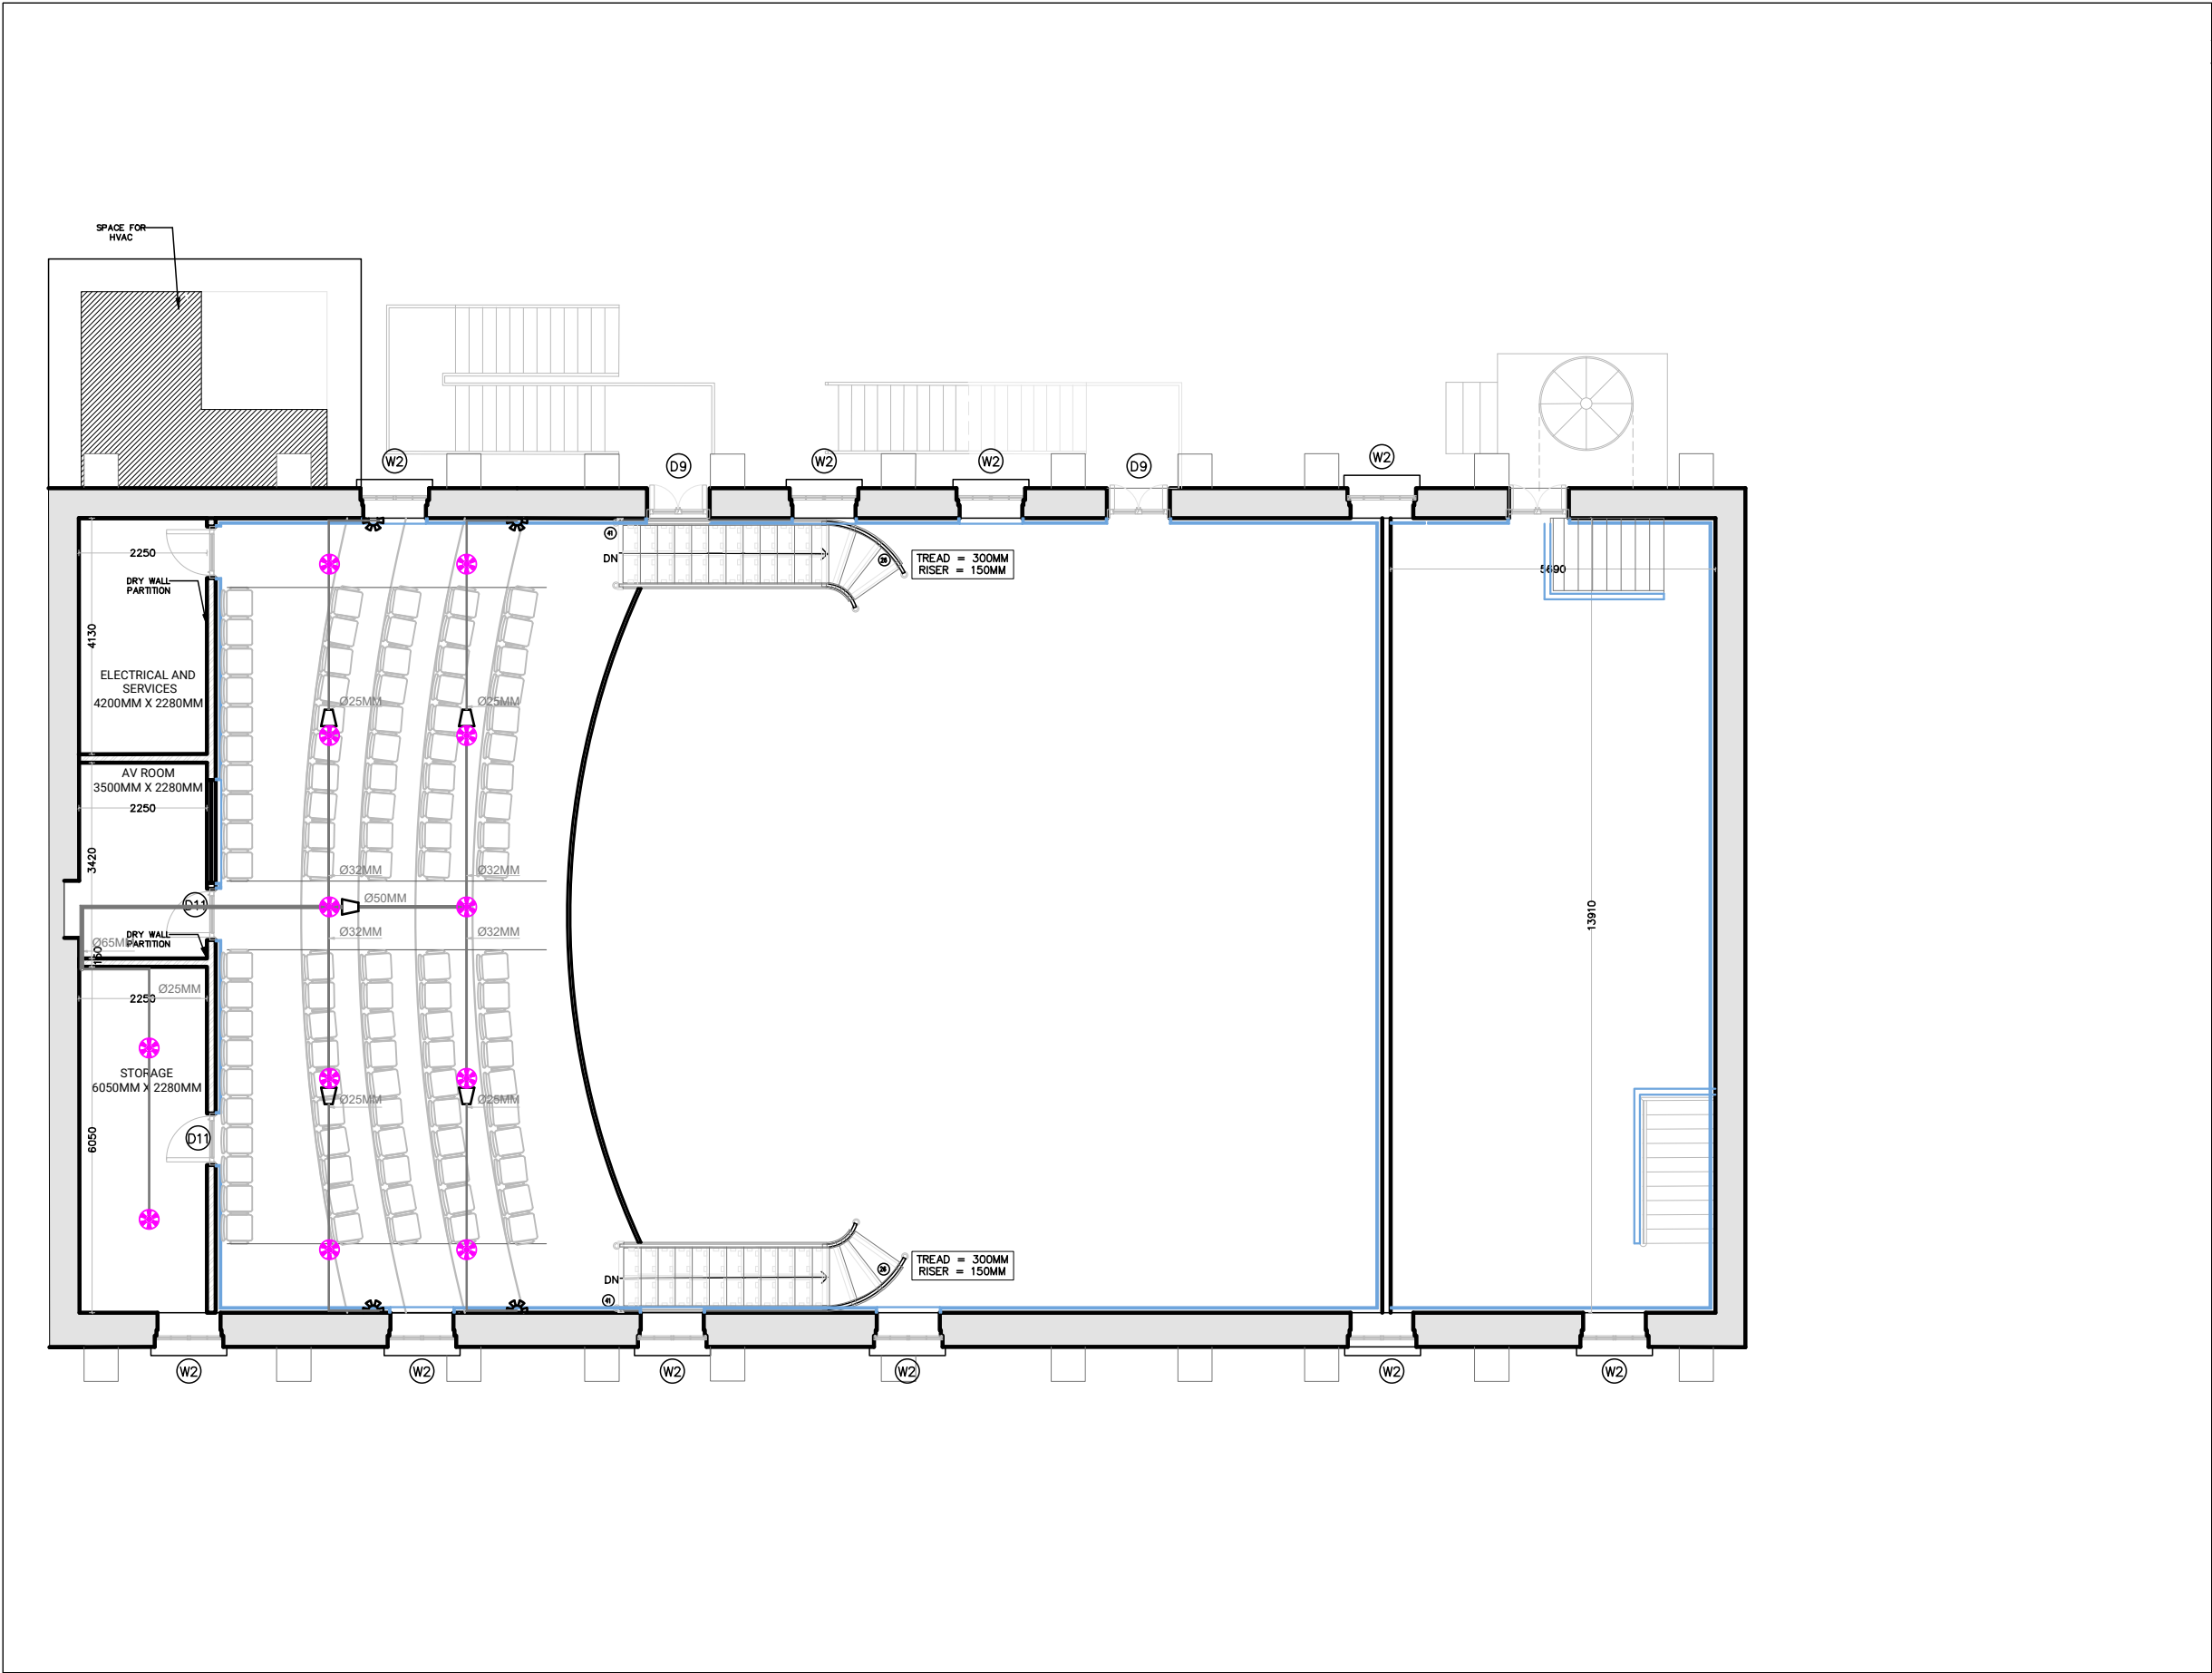

- GENERAL NOTES:-
1. ALL DIMENSIONS ARE IN MILLIMETERS UNLESS OTHERWISE STATED.
 2. DO NOT SCALE THIS DRAWING - WORK TO FIGURED DIMENSIONS ONLY.
 3. THIS DRAWING IS THE EXCLUSIVE PROPERTY OF KETAN A SHAH & ASSOCIATES .
 4. REPRODUCTION IN ANY FORM WITHOUT THE WRITTEN CONSENT OF THE AFOREMENTIONED IS STRICTLY PROHIBITED.

-	-	-	-
R4	REVISED AS PER COMMENT		08.06.2026
R3	REVISED AS PER COMMENT		22.05.2026
R2	REVISED AS PER LATEST RCP		21.05.2026
R1	REVISED AS PER NEW LAYOUT		19.05.2026
NO.	REVISION	OWN	DATE

HVAC CONSULTANT **KASA**
KETAN A. SHAH & ASSOCIATES
701- B.Silverline Apt., 51st TPS Road,
Borivli (W), Mumbai 400 092.
Phone : +91 8850616843
E-mail : Ketansha@gmail

Architect :
AISHWARYA TIPNIS ARCHITECTS

Client :
LAWRENCE SCHOOL
SANWAR


Project :
AUDITORIUM

Drawing Title :
FIRE FIGHTING LAYOUT: BALCONY

Drawn By : JITEN **Checked By :** UMESH **Approved By :** KAS

JOB NO: FF/2704 **Scale :** NTS **Date :** 08.06.2026

Drawing No : FF/02 **Revision :** R4

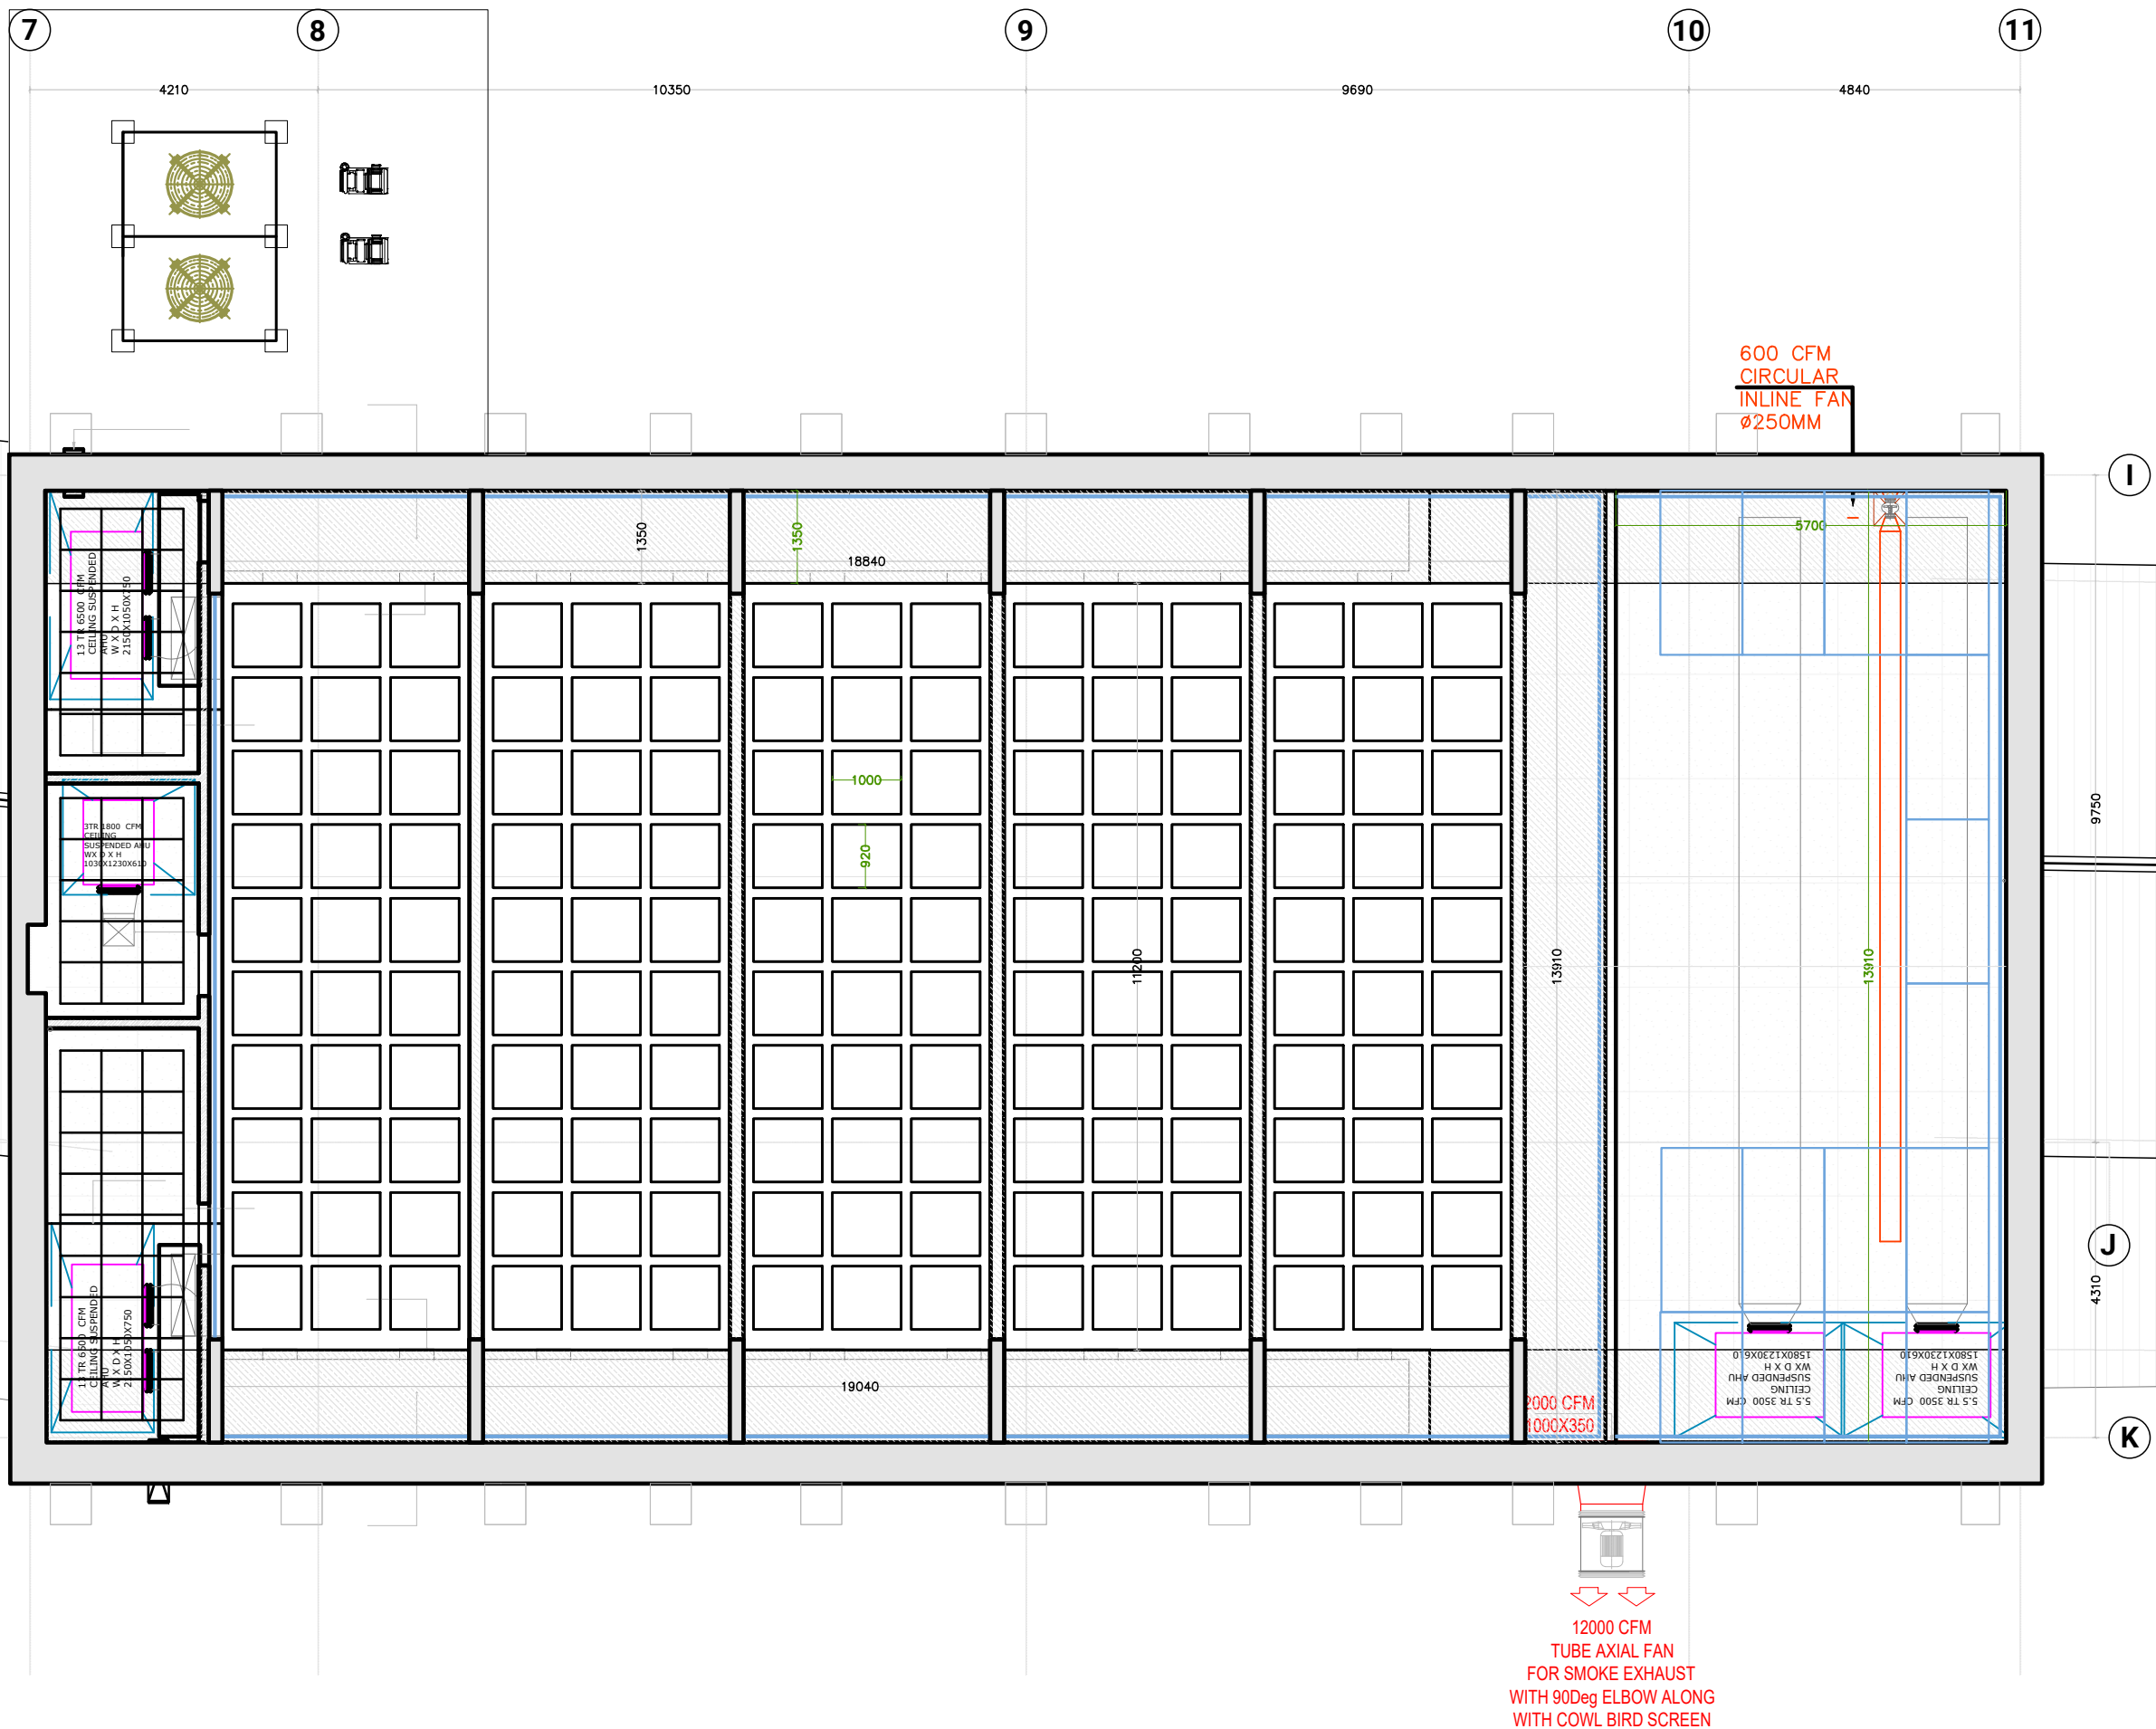

GENERAL NOTES:-
1. ALL DIMENSIONS ARE IN MILLIMETERS UNLESS OTHERWISE STATED.
2. DO NOT SCALE THIS DRAWING - WORK TO FIGURED DIMENSIONS ONLY.
3. THIS DRAWING IS THE EXCLUSIVE PROPERTY OF KETAN A SHAH & ASSOCIATES.
4. REPRODUCTION IN ANY FORM WITHOUT THE WRITTEN CONSENT OF THE AFOREMENTIONED IS STRICTLY PROHIBITED.

R6	REVISED AS PER DISCUSSION	08.06.2026
R5	REVISED AS PER COMMENT	22.05.2026
R4	REVISED AS PER LATEST RCP	21.05.2026
R3	REVISED AS PER NEW LAYOUT	19.05.2026
R2	REVISED AS PER COMMENT	04.05.2026
R1	REVISED AS PER NEW LAYOUT	28.04.2026
NO.	REASON	DATE

HVAC CONSULTANT **KASA**
KETAN A. SHAH & ASSOCIATES
701- B, Silverline Apt., 51st TPS Road,
Borivli (W), Mumbai 400 092.
Phone : +91 8850616843
E-mail : Ketanashah@gmail


Architect :
AISHWARYA TIPNIS ARCHITECTS

Client :
LAWRENCE SCHOOL
SANWAR

Project :
AUDITORIUM

Drawing Title :
HVAC LAYOUT- FIRST FLOOR

Drawn By : JITEN	Checked By : UMESH	Approved By : KAS
JOB NO: AC/2704	Scale : NTS	Date : 08.06.2026
Drawing No : HVAC/01		Revision : R6

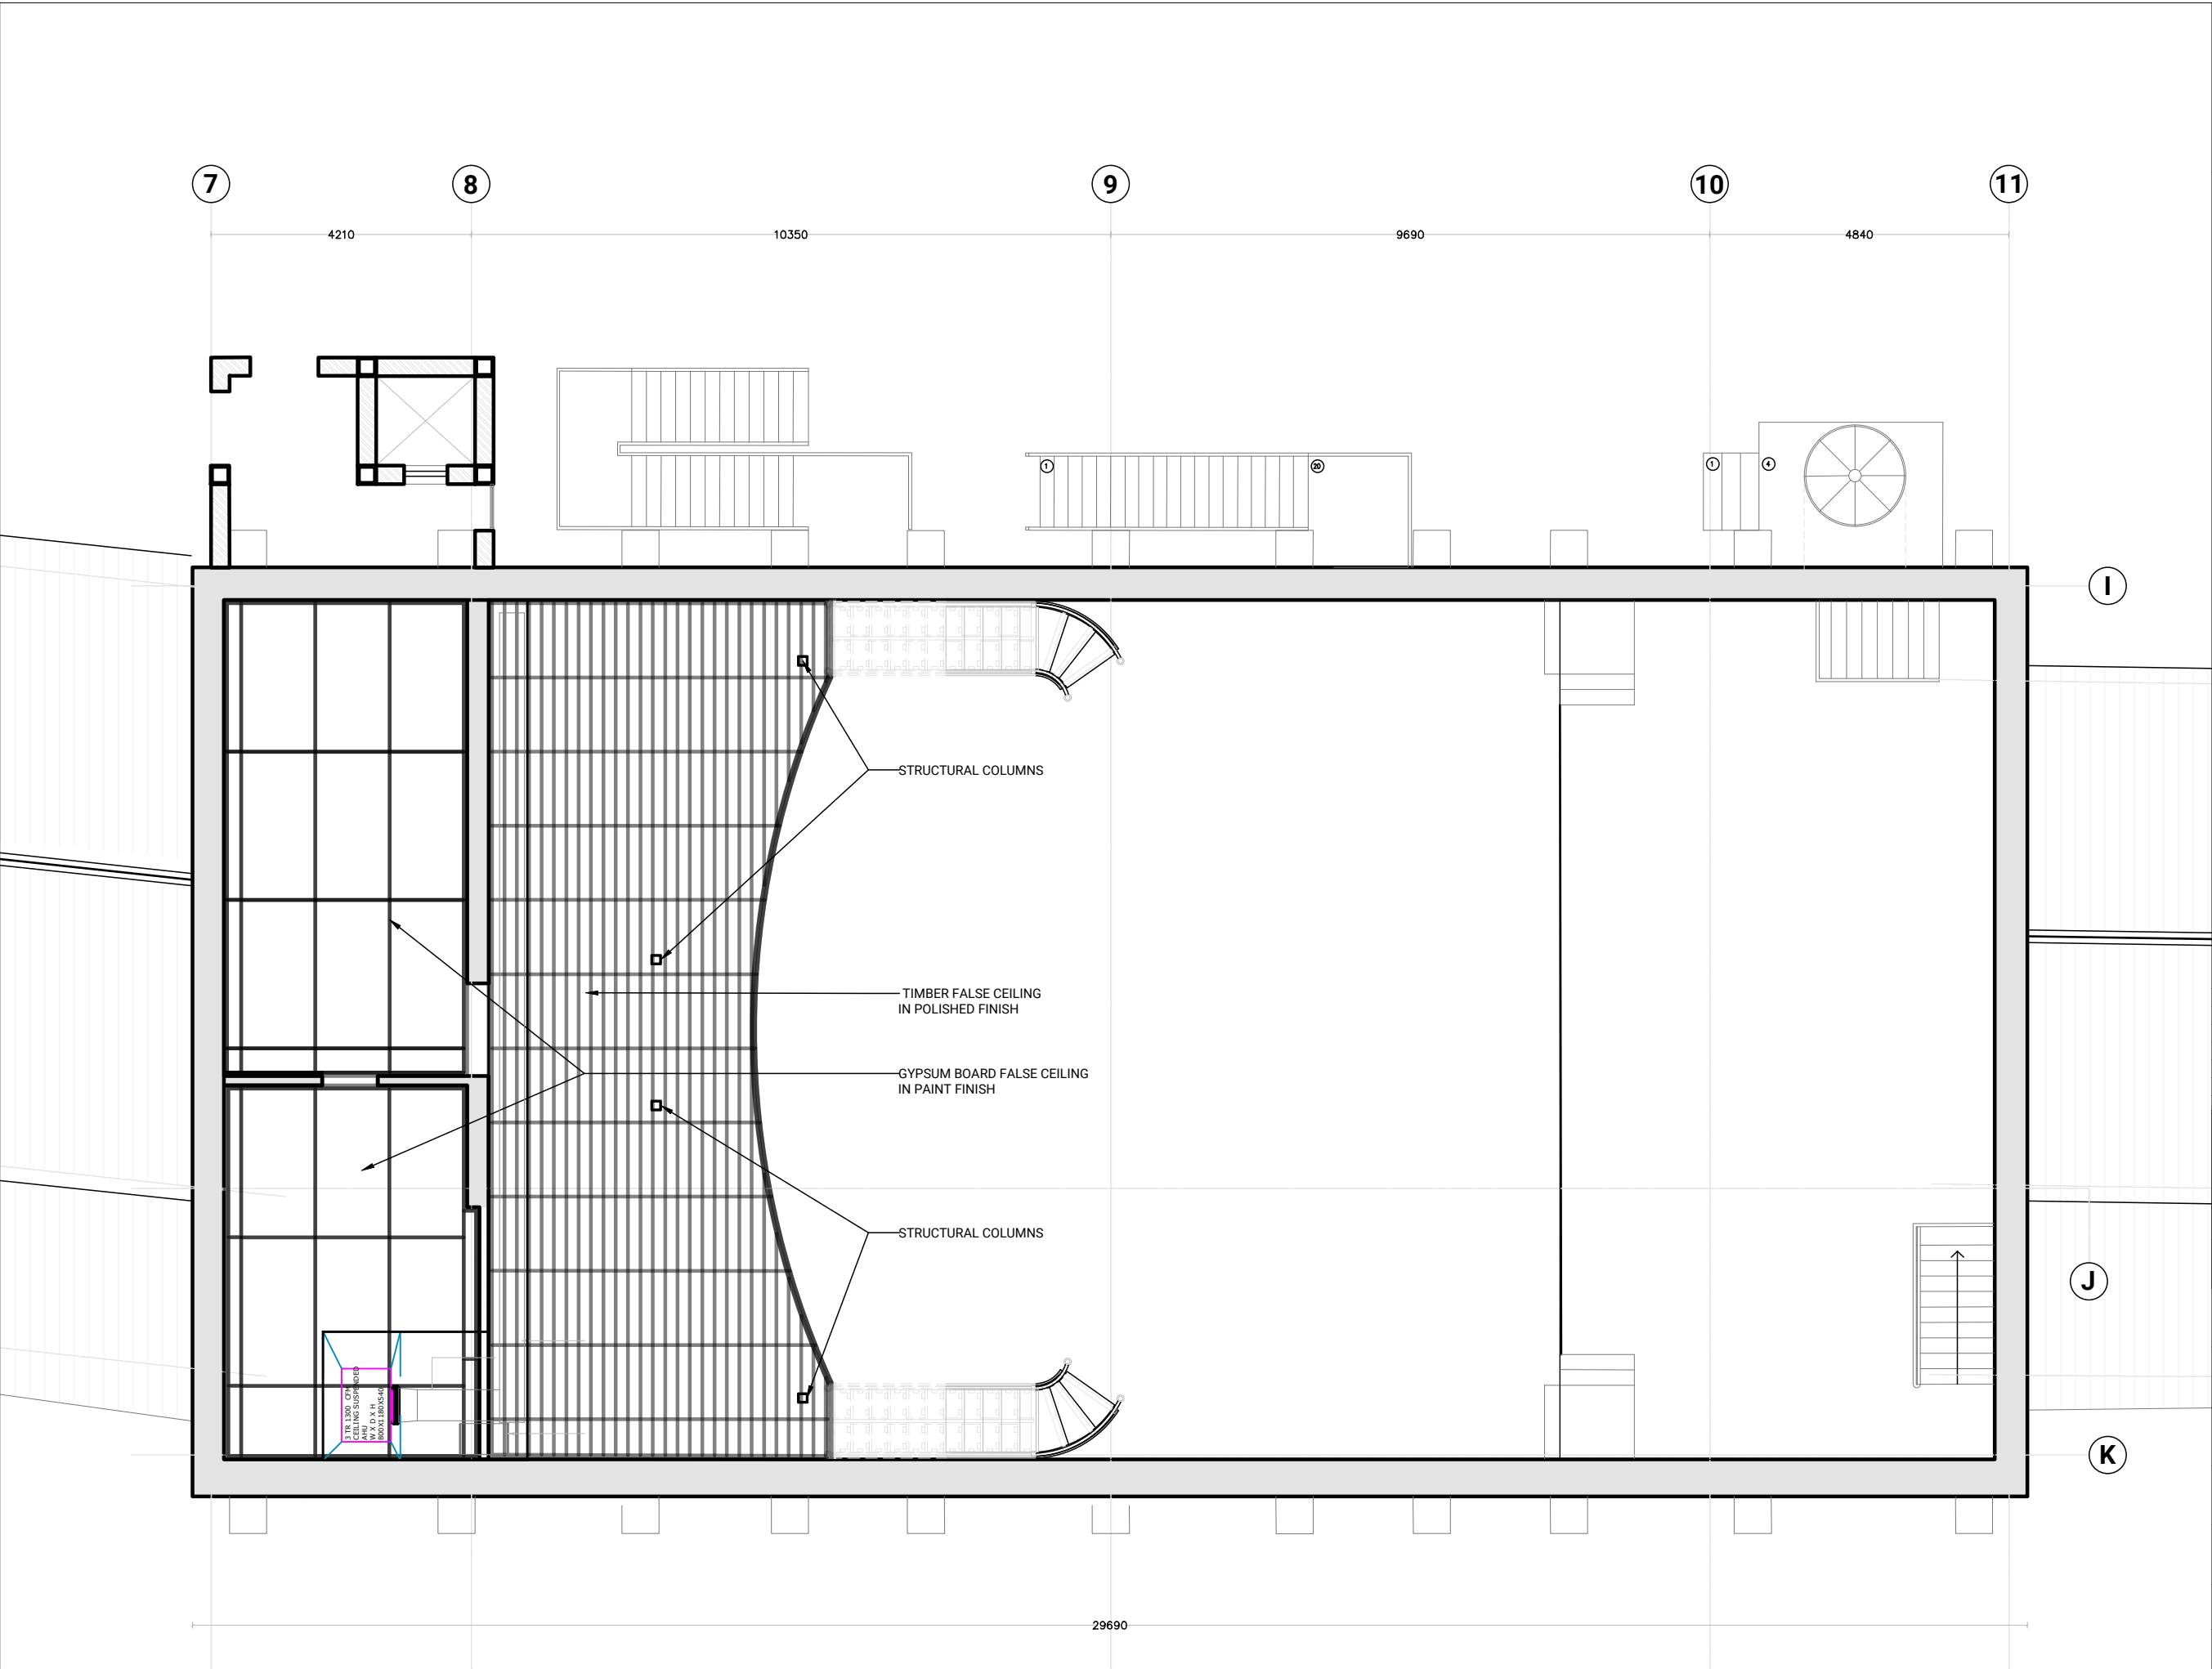

GENERAL NOTES:-
1. ALL DIMENSIONS ARE IN MILLIMETERS UNLESS OTHERWISE STATED.
2. DO NOT SCALE THIS DRAWING - WORK TO FIGURED DIMENSIONS ONLY.
3. THIS DRAWING IS THE EXCLUSIVE PROPERTY OF KETAN A SHAH & ASSOCIATES .
4. REPRODUCTION IN ANY FORM WITHOUT THE WRITTEN CONSENT OF THE AFOREMENTIONED IS STRICTLY PROHIBITED.

R6	REVISED AS PER DISCUSSION		08.06.2026
R5	REVISED AS PER COMMENT		22.05.2026
R4	REVISED AS PER LATEST RCP		21.05.2026
R3	REVISED AS PER NEW LAYOUT		19.05.2026
R2	REVISED AS PER COMMENT		04.05.2026
R1	REVISED AS PER NEW LAYOUT		28.04.2026

NO.	REVISION	SUN	DATE
-----	----------	-----	------

HVAC CONSULTANT **KASA**
KETAN A. SHAH & ASSOCIATES
701- B,Silverline Apt., 51st TPS Road,
Borivli (W), Mumbai 400 092.
Phone : +91 8850616843
E-mail : Ketanshah@gmail

Architect :
AISHWARYA TIPNIS ARCHITECTS

Client :
LAWRENCE SCHOOL
SANWAR


Project :
AUDITORIUM

Drawing Title :
HVAC LAYOUT- BALCONY

Drawn By : JITEN	Checked By : UMESH	Approved By : KAS
----------------------------	------------------------------	-----------------------------

JOB NO: AC/2704	Scale : NTS	Date : 08.06.2026
---------------------------	-----------------------	-----------------------------

Drawing No : HVAC/02	Revision : R6
--------------------------------	-------------------------

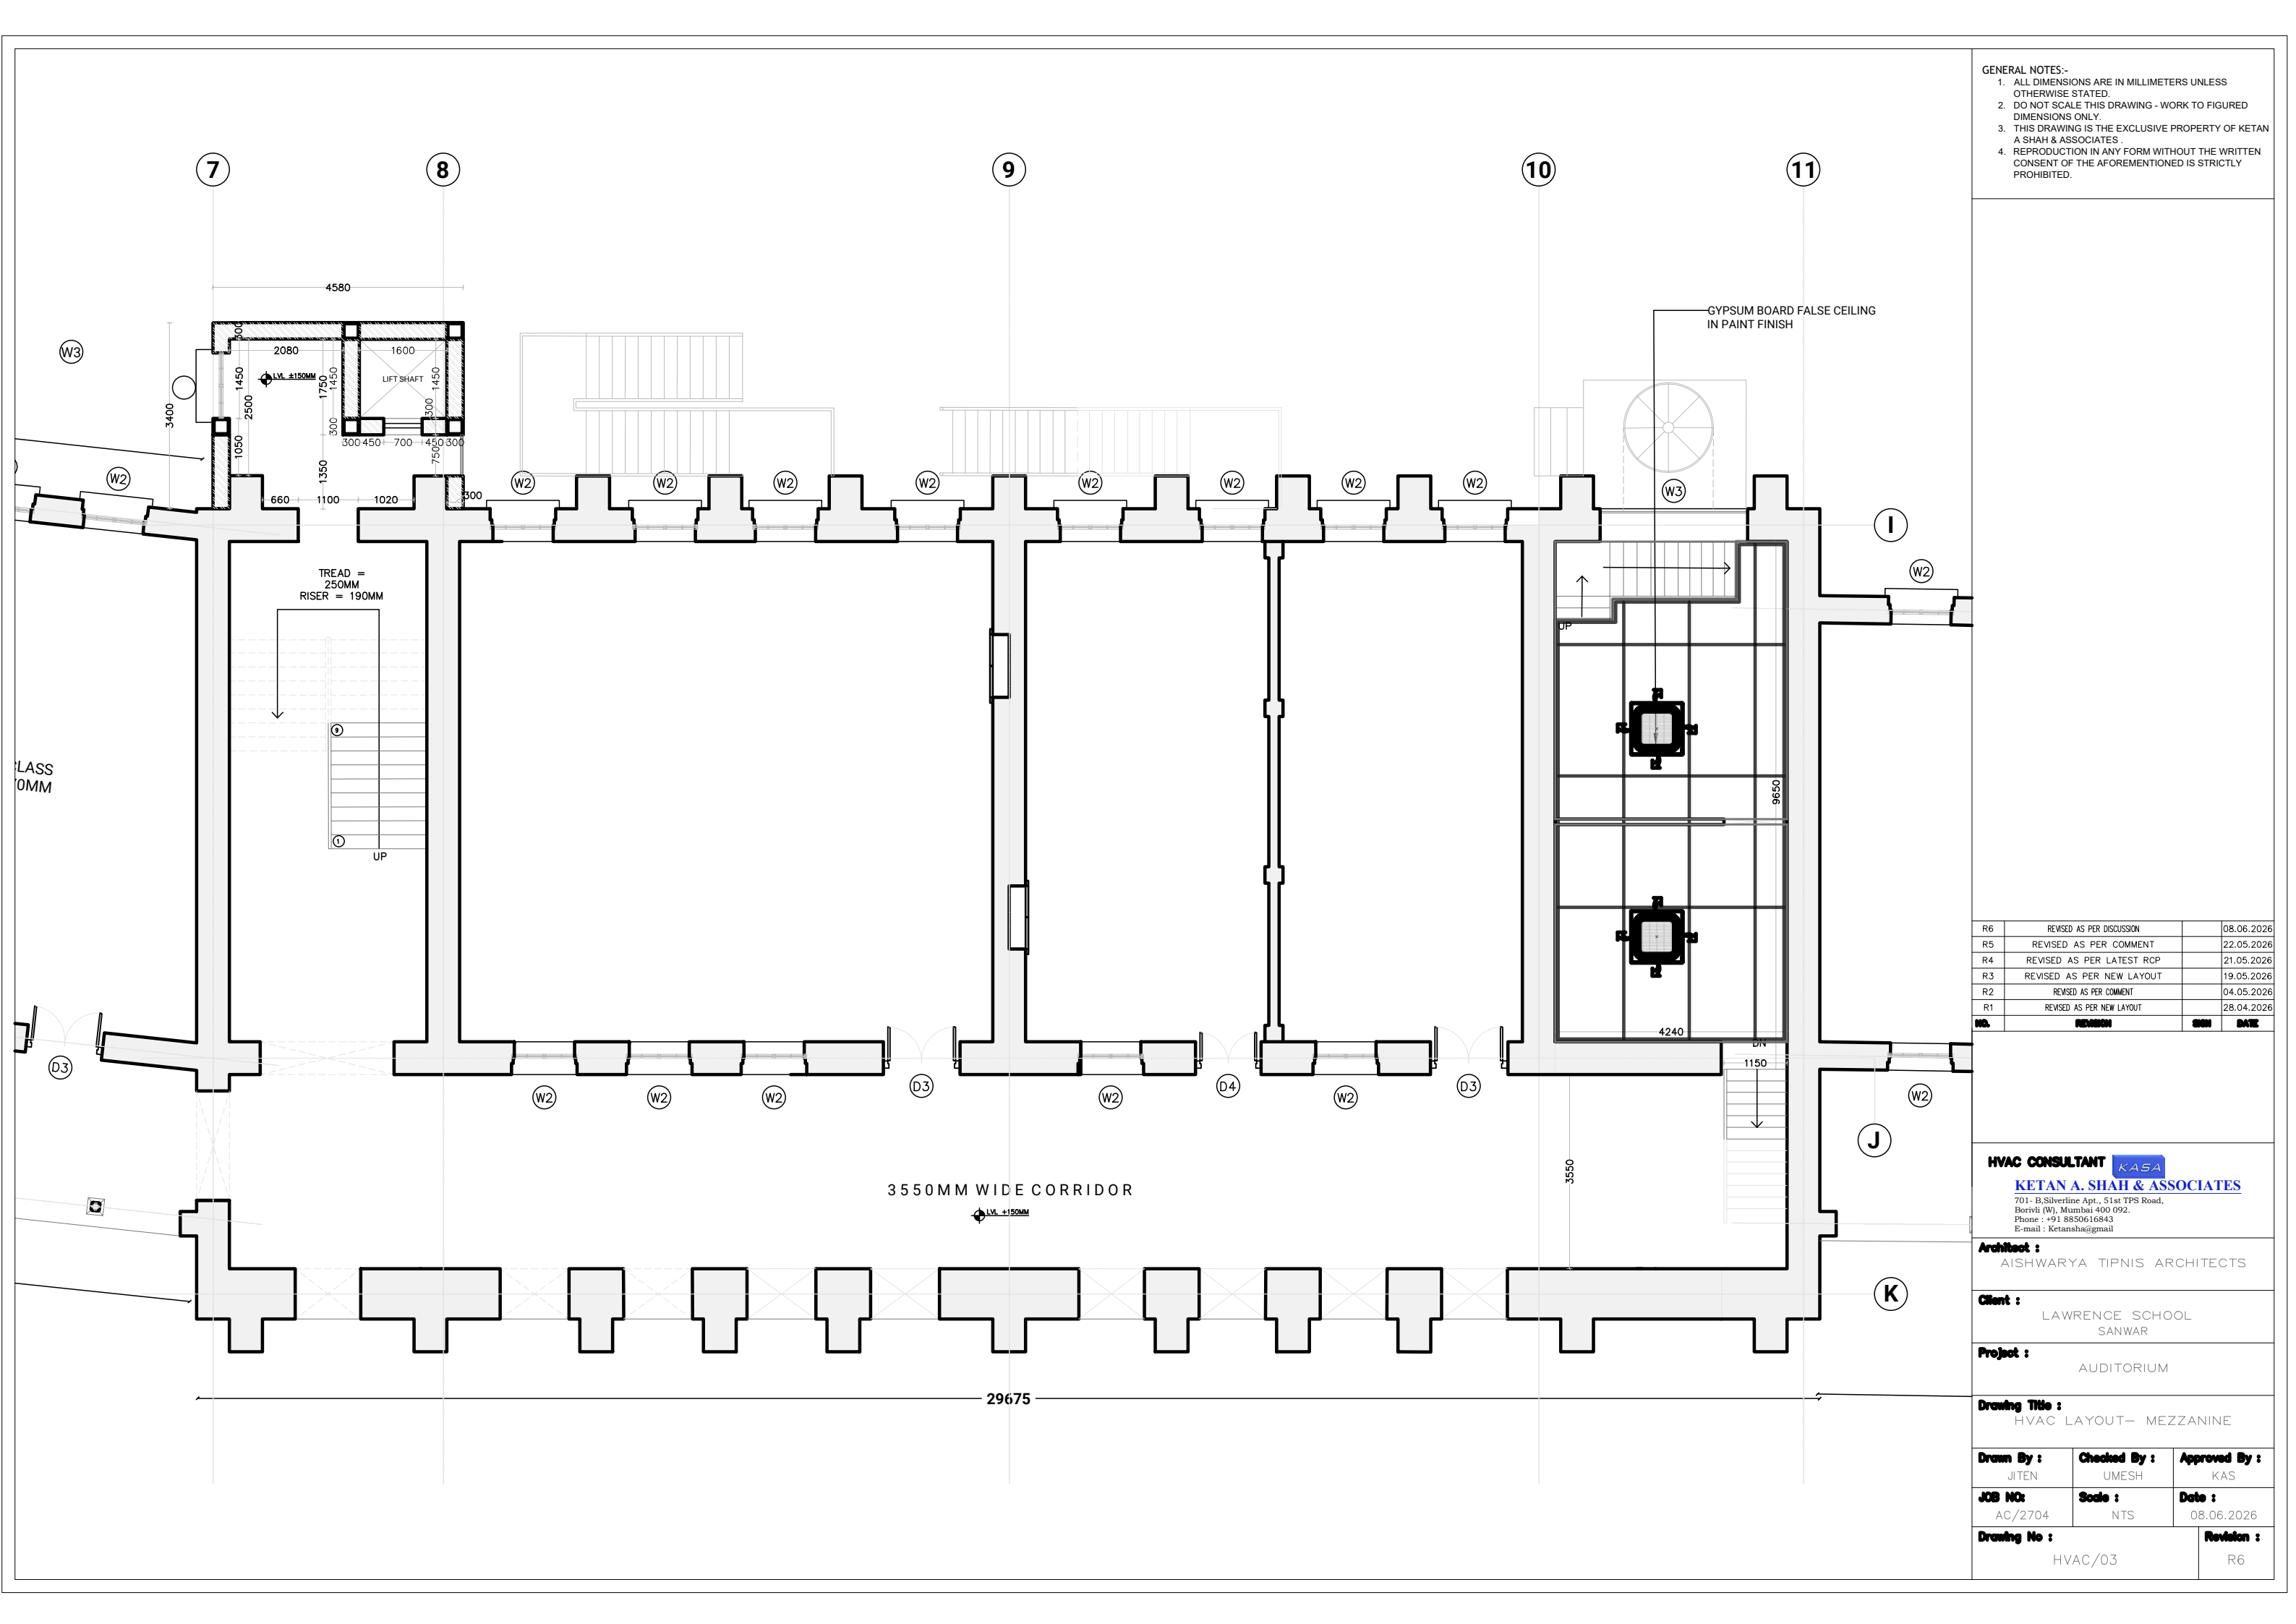

GENERAL NOTES:-
1. ALL DIMENSIONS ARE IN MILLIMETERS UNLESS OTHERWISE STATED.
2. DO NOT SCALE THIS DRAWING - WORK TO FIGURED DIMENSIONS ONLY.
3. THIS DRAWING IS THE EXCLUSIVE PROPERTY OF KETAN A SHAH & ASSOCIATES.
4. REPRODUCTION IN ANY FORM WITHOUT THE WRITTEN CONSENT OF THE AFOREMENTIONED IS STRICTLY PROHIBITED.

R6	REVISED AS PER DISCUSSION	08.06.2026
R5	REVISED AS PER COMMENT	22.05.2026
R4	REVISED AS PER LATEST RCP	21.05.2026
R3	REVISED AS PER NEW LAYOUT	19.05.2026
R2	REVISED AS PER COMMENT	04.05.2026
R1	REVISED AS PER NEW LAYOUT	28.04.2026
NO.	REVISION	SUN DATE

HVAC CONSULTANT **KASA**
KETAN A. SHAH & ASSOCIATES
701- B, Silverline Apt., 51st TPS Road,
Borivli (W), Mumbai 400 092.
Phone : +91 8850616843
E-mail : Ketanashah@gmail

Architect :
AISHWARYA TIPNIS ARCHITECTS

Client :
LAWRENCE SCHOOL
SANWAR


Project :
AUDITORIUM

Drawing Title :
HVAC LAYOUT- MEZZANINE

Drawn By : JITEN	Checked By : UMESH	Approved By : KAS
---------------------	-----------------------	----------------------

JOB NO: AC/2704	Scale : NTS	Date : 08.06.2026
--------------------	----------------	----------------------

Drawing No : HVAC/03	Revision : R6
-------------------------	------------------

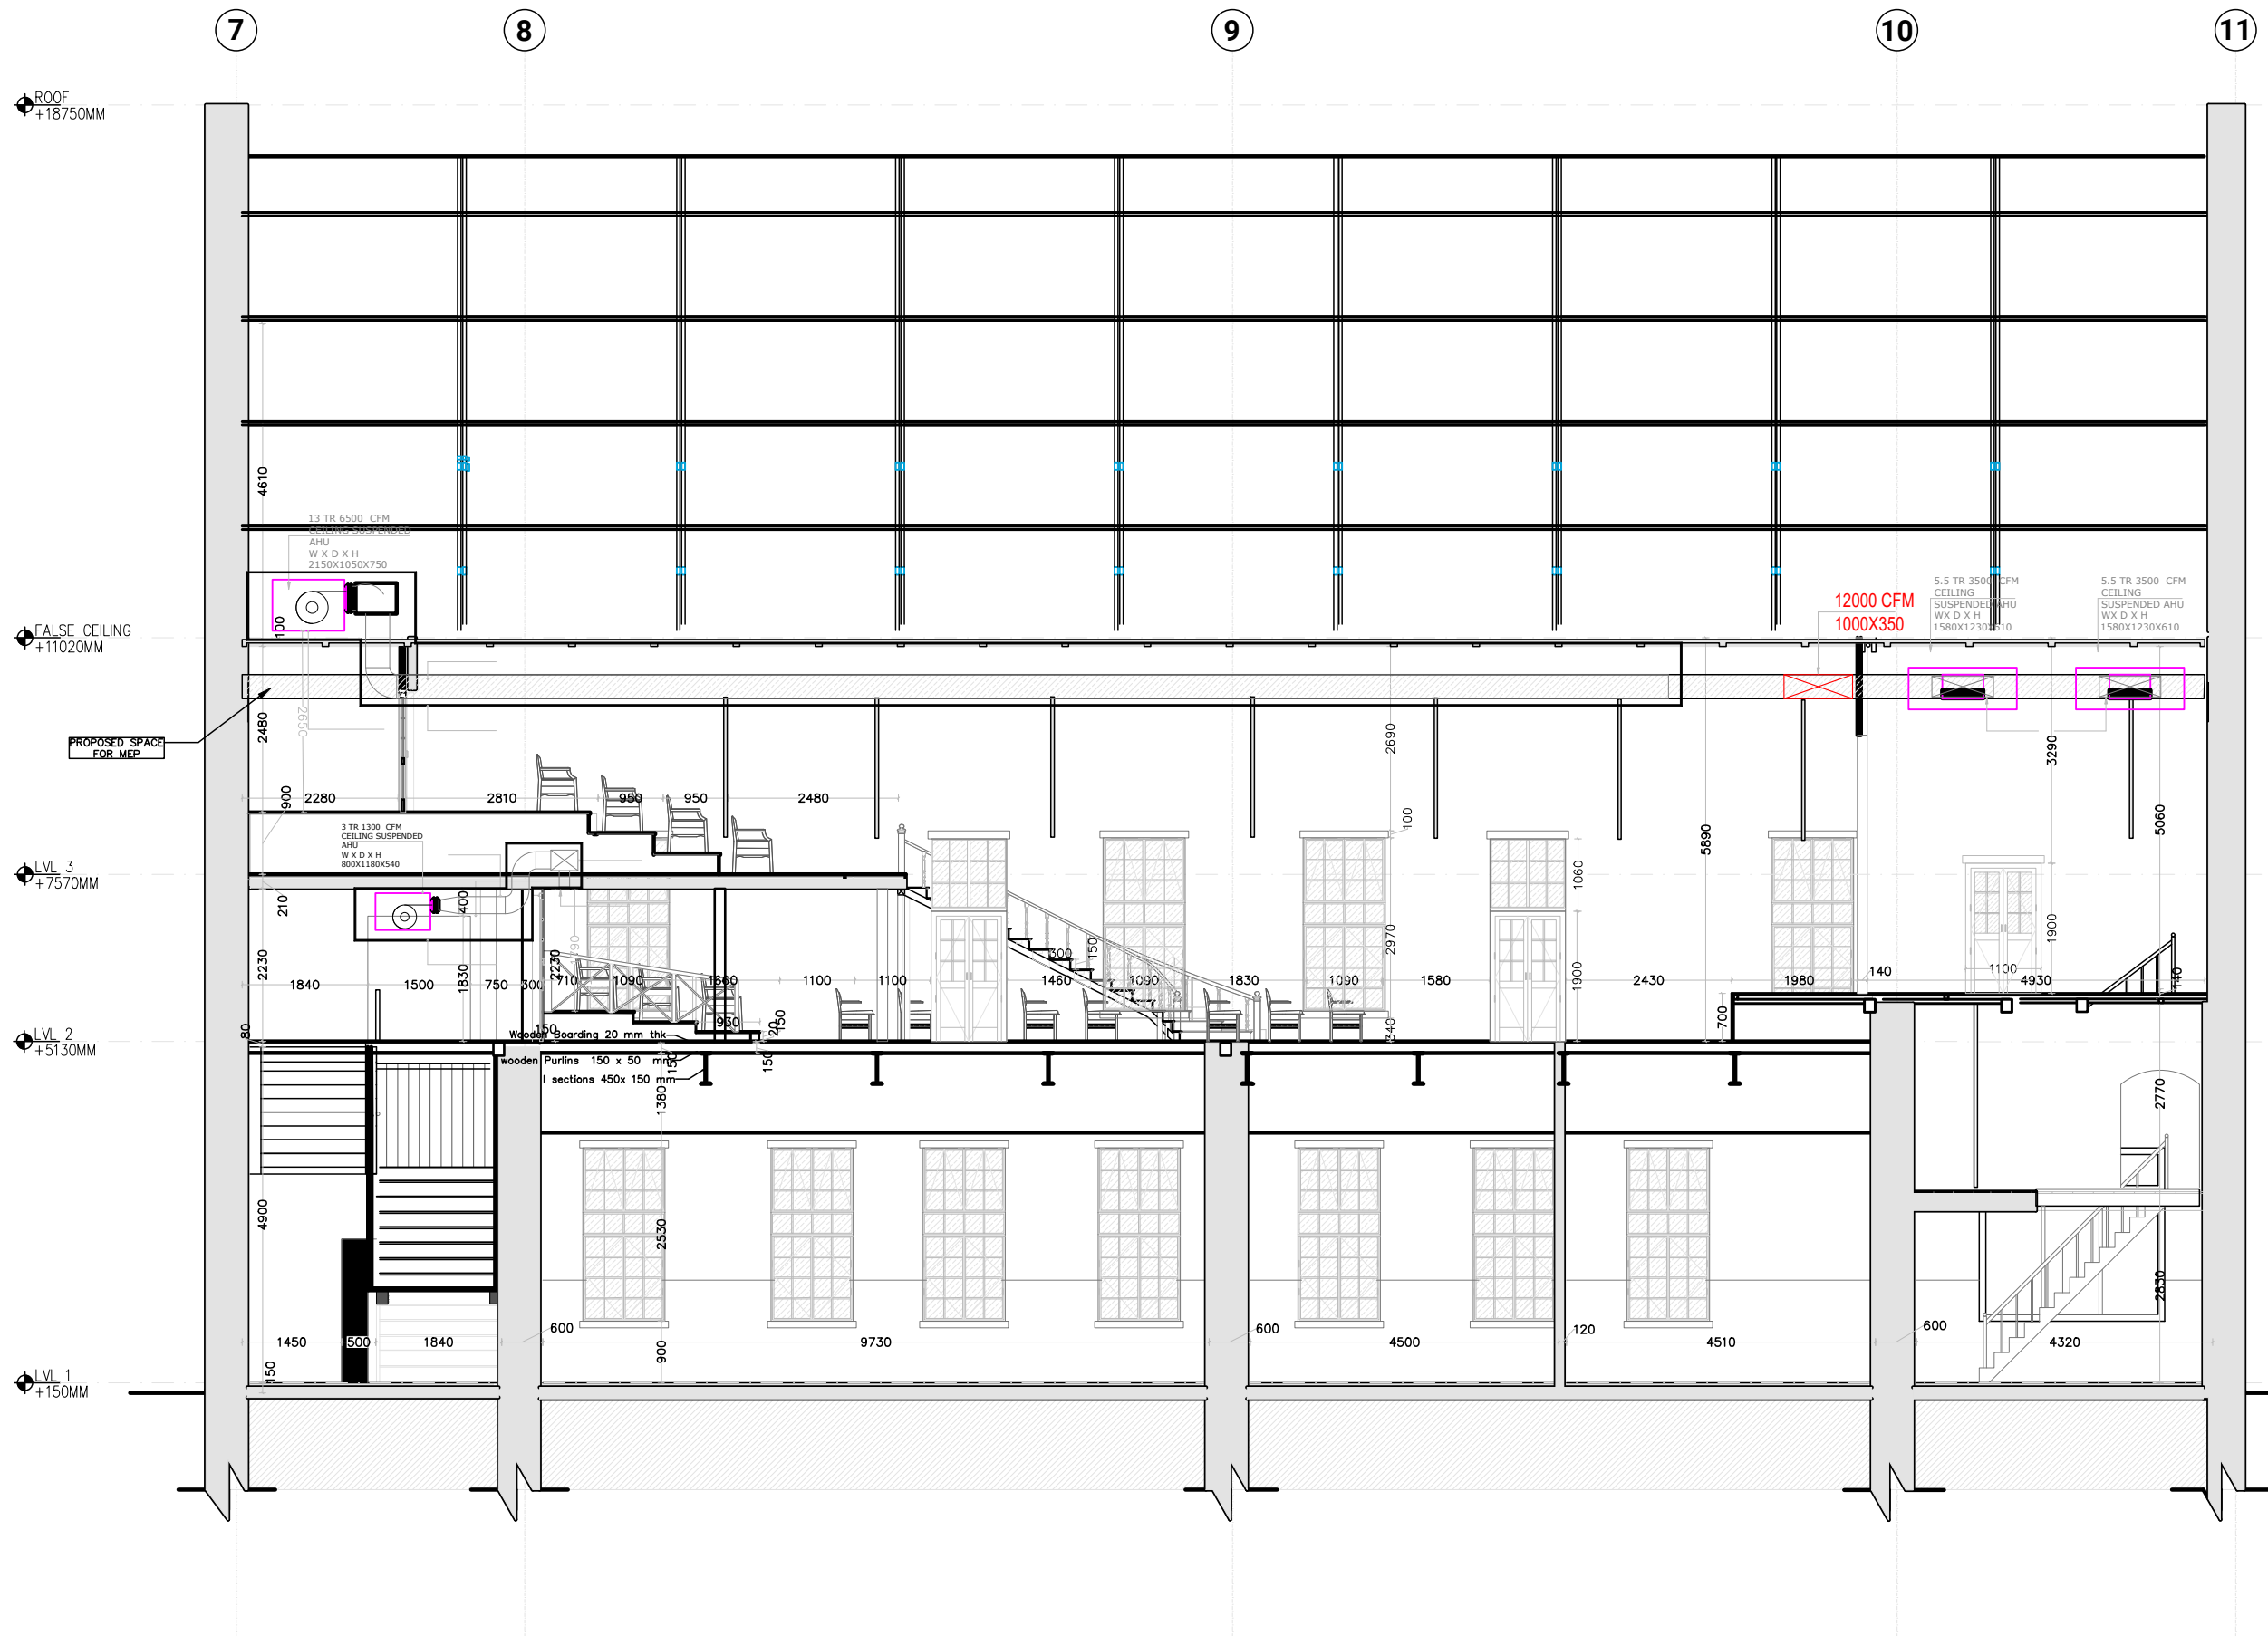

- GENERAL NOTES:-
1. ALL DIMENSIONS ARE IN MILLIMETERS UNLESS OTHERWISE STATED.
 2. DO NOT SCALE THIS DRAWING - WORK TO FIGURED DIMENSIONS ONLY.
 3. THIS DRAWING IS THE EXCLUSIVE PROPERTY OF KETAN A SHAH & ASSOCIATES.
 4. REPRODUCTION IN ANY FORM WITHOUT THE WRITTEN CONSENT OF THE AFOREMENTIONED IS STRICTLY PROHIBITED.

R6	REVISED AS PER DISCUSSION	08.06.2026
R5	REVISED AS PER COMMENT	22.05.2026
R4	REVISED AS PER LATEST RCP	21.05.2026
R3	REVISED AS PER NEW LAYOUT	19.05.2026
R2	REVISED AS PER COMMENT	04.05.2026
R1	REVISED AS PER NEW LAYOUT	28.04.2026

NO.	REVISION	SUN	DATE
-----	----------	-----	------

HVAC CONSULTANT **KASA**
KETAN A. SHAH & ASSOCIATES
701- B, Silverline Apt., 51st TPS Road,
Borivli (W), Mumbai 400 092.
Phone : +91 8850616843
E-mail : Ketanshah@gmail

Architect :
AISHWARYA TIPNIS ARCHITECTS

Client :
LAWRENCE SCHOOL
SANWAR


Project :
AUDITORIUM

Drawing Title :
HVAC LAYOUT- SECTION AA'

Drawn By : JITEN	Checked By : UMESH	Approved By : KAS
----------------------------	------------------------------	-----------------------------

JOB NO: AC/2704	Scale : NTS	Date : 08.06.2026
---------------------------	-----------------------	-----------------------------

Drawing No : HVAC/04	Revision : R6
--------------------------------	-------------------------

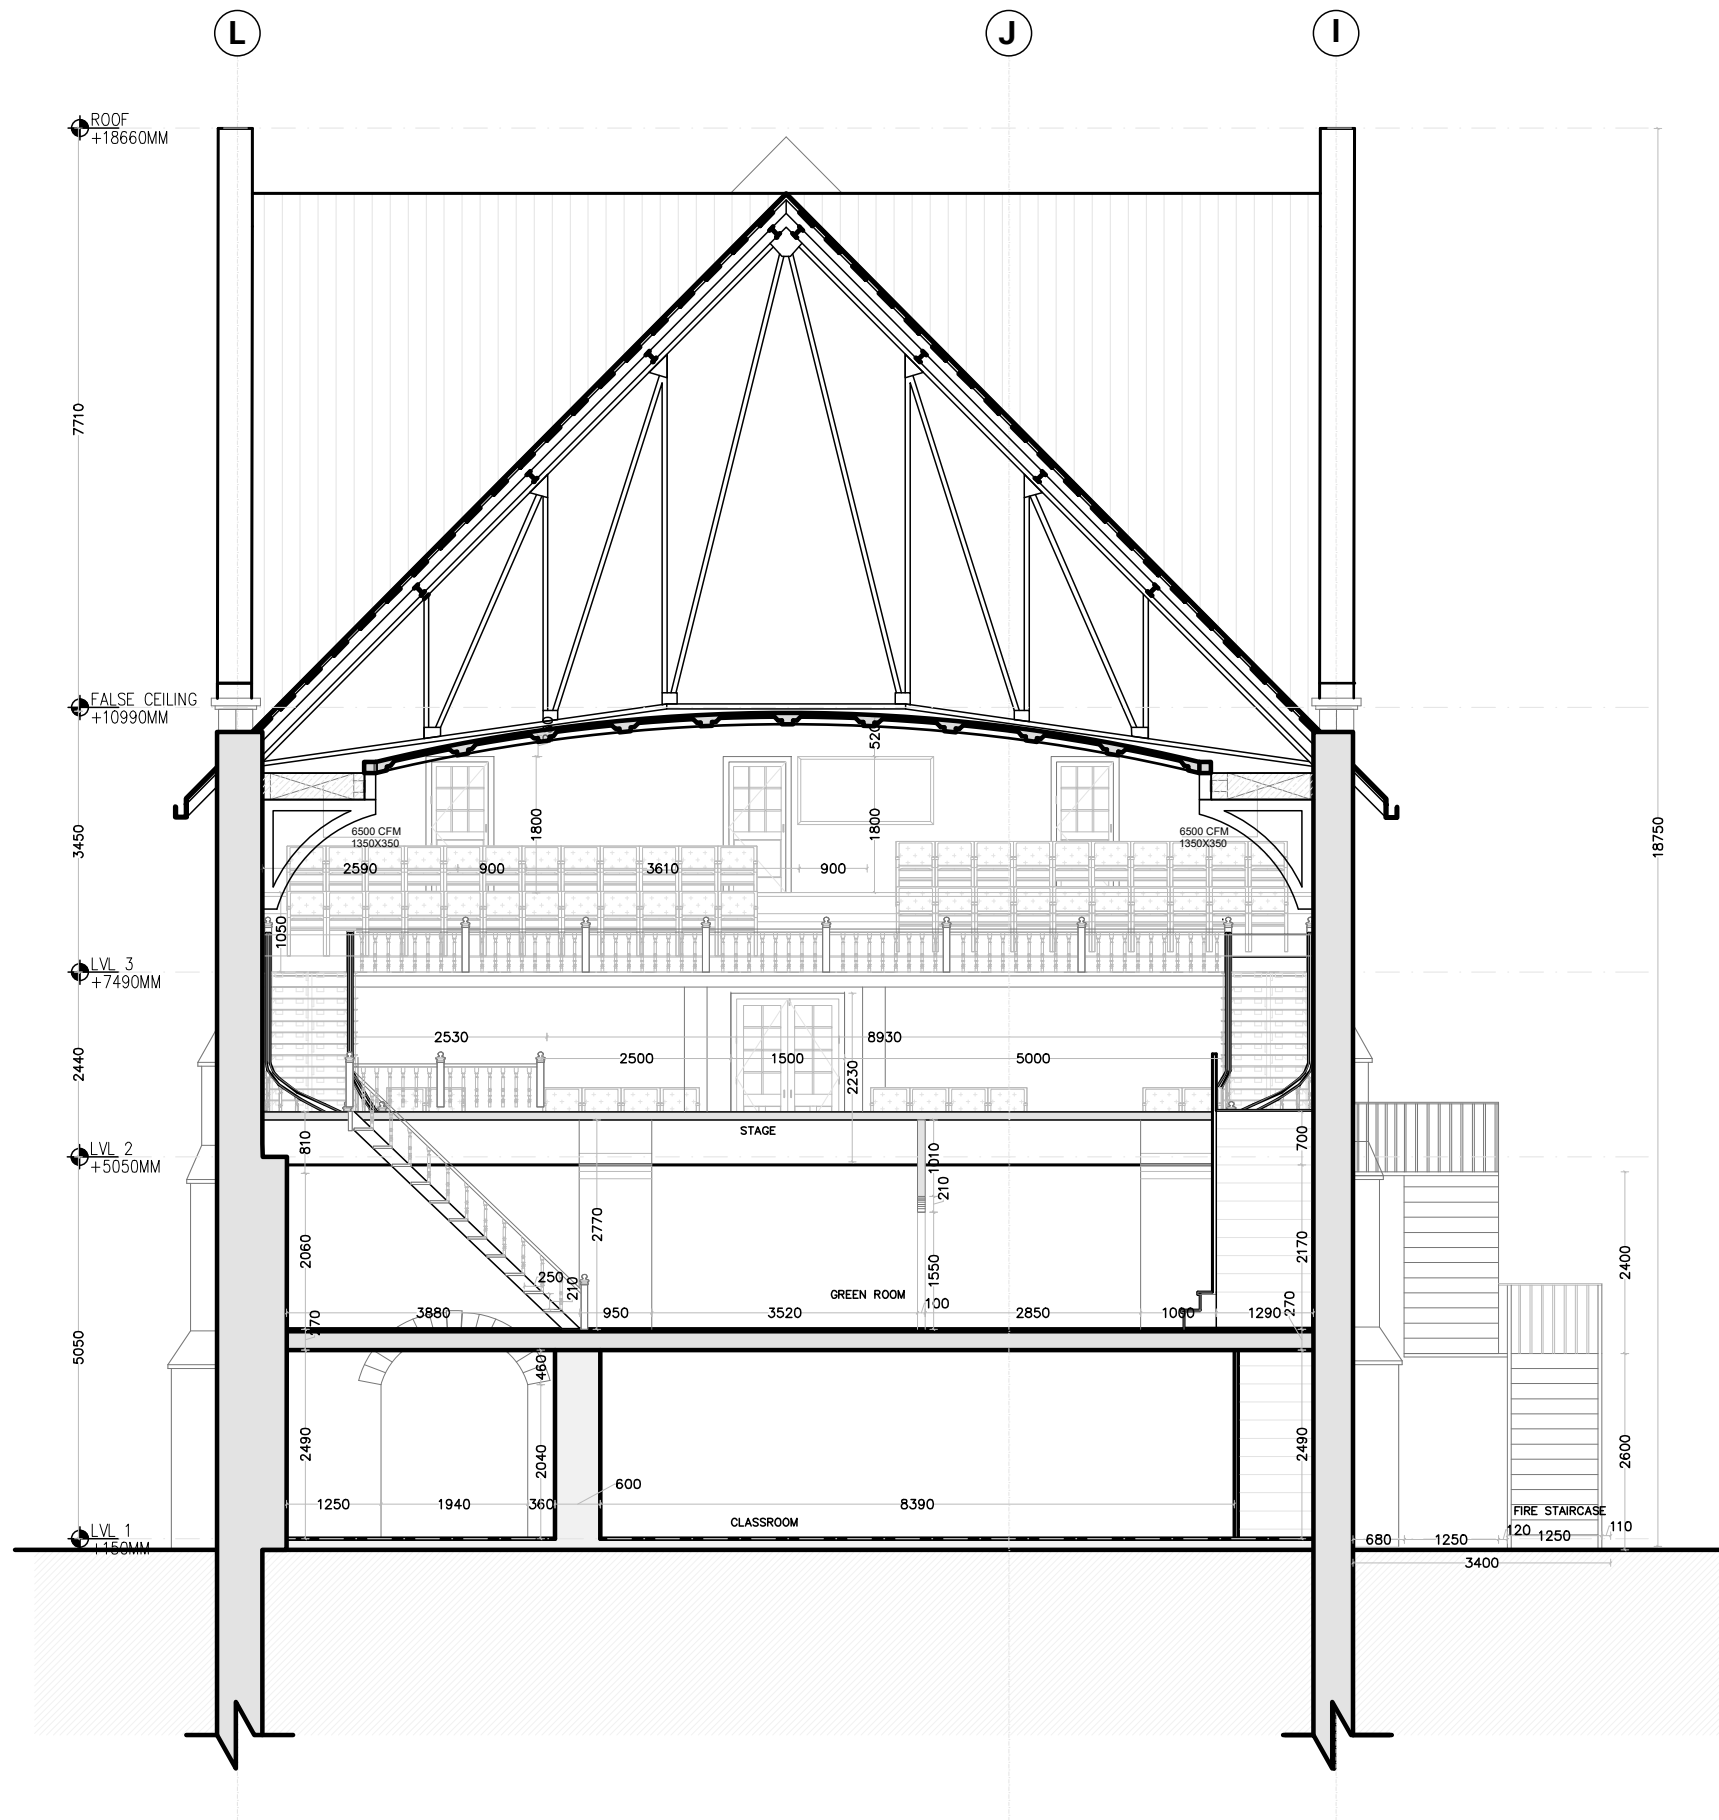

GENERAL NOTES:-

1. ALL DIMENSIONS ARE IN MILLIMETERS UNLESS OTHERWISE STATED.
2. DO NOT SCALE THIS DRAWING - WORK TO FIGURED DIMENSIONS ONLY.
3. THIS DRAWING IS THE EXCLUSIVE PROPERTY OF KETAN A SHAH & ASSOCIATES .
4. REPRODUCTION IN ANY FORM WITHOUT THE WRITTEN CONSENT OF THE AFOREMENTIONED IS STRICTLY PROHIBITED.

R6	REVISED AS PER DISCUSSION		08.06.2026
R5	REVISED AS PER COMMENT		22.05.2026
R4	REVISED AS PER LATEST RCP		21.05.2026
R3	REVISED AS PER NEW LAYOUT		19.05.2026
R2	REVISED AS PER COMMENT		04.05.2026
R1	REVISED AS PER NEW LAYOUT		28.04.2026

NO.	REASON	SUN	DATE
-----	--------	-----	------

HVAC CONSULTANT **KASA**
KETAN A. SHAH & ASSOCIATES
701- B,Silverline Apt., 51st TPS Road,
Borivli (W), Mumbai 400 092.
Phone : +91 8850616843
E-mail : Ketanashah@gmail

Architect :
AISHWARYA TIPNIS ARCHITECTS

Client :
LAWRENCE SCHOOL
SANWAR

Project :
AUDITORIUM

Drawing Title :
HVAC LAYOUT- SECTION CC'

Drawn By : JITEN	Checked By : UMESH	Approved By : KAS
---------------------	-----------------------	----------------------

JOB NO: AC/2704	Scale : NTS	Date : 08.06.2026
--------------------	----------------	----------------------

Drawing No : HVAC/05	Revision : R6
-------------------------	------------------



AISHWARYA TIPNIS ARCHITECTS

83-D, DDA Flats, Masjid Moth
Phase II, Greater Kailash III,
New Delhi-110048

projects@studioata.in

www.studioata.in

T: +91 11 29221690 | M: +91 9873926616